

HARRIMAN


 
AUBURN PORTLAND MANCHESTER

HARTT
TRANSPORTATION

Auburn, ME

Harriman Project No. 14507

Key Plan Prog North

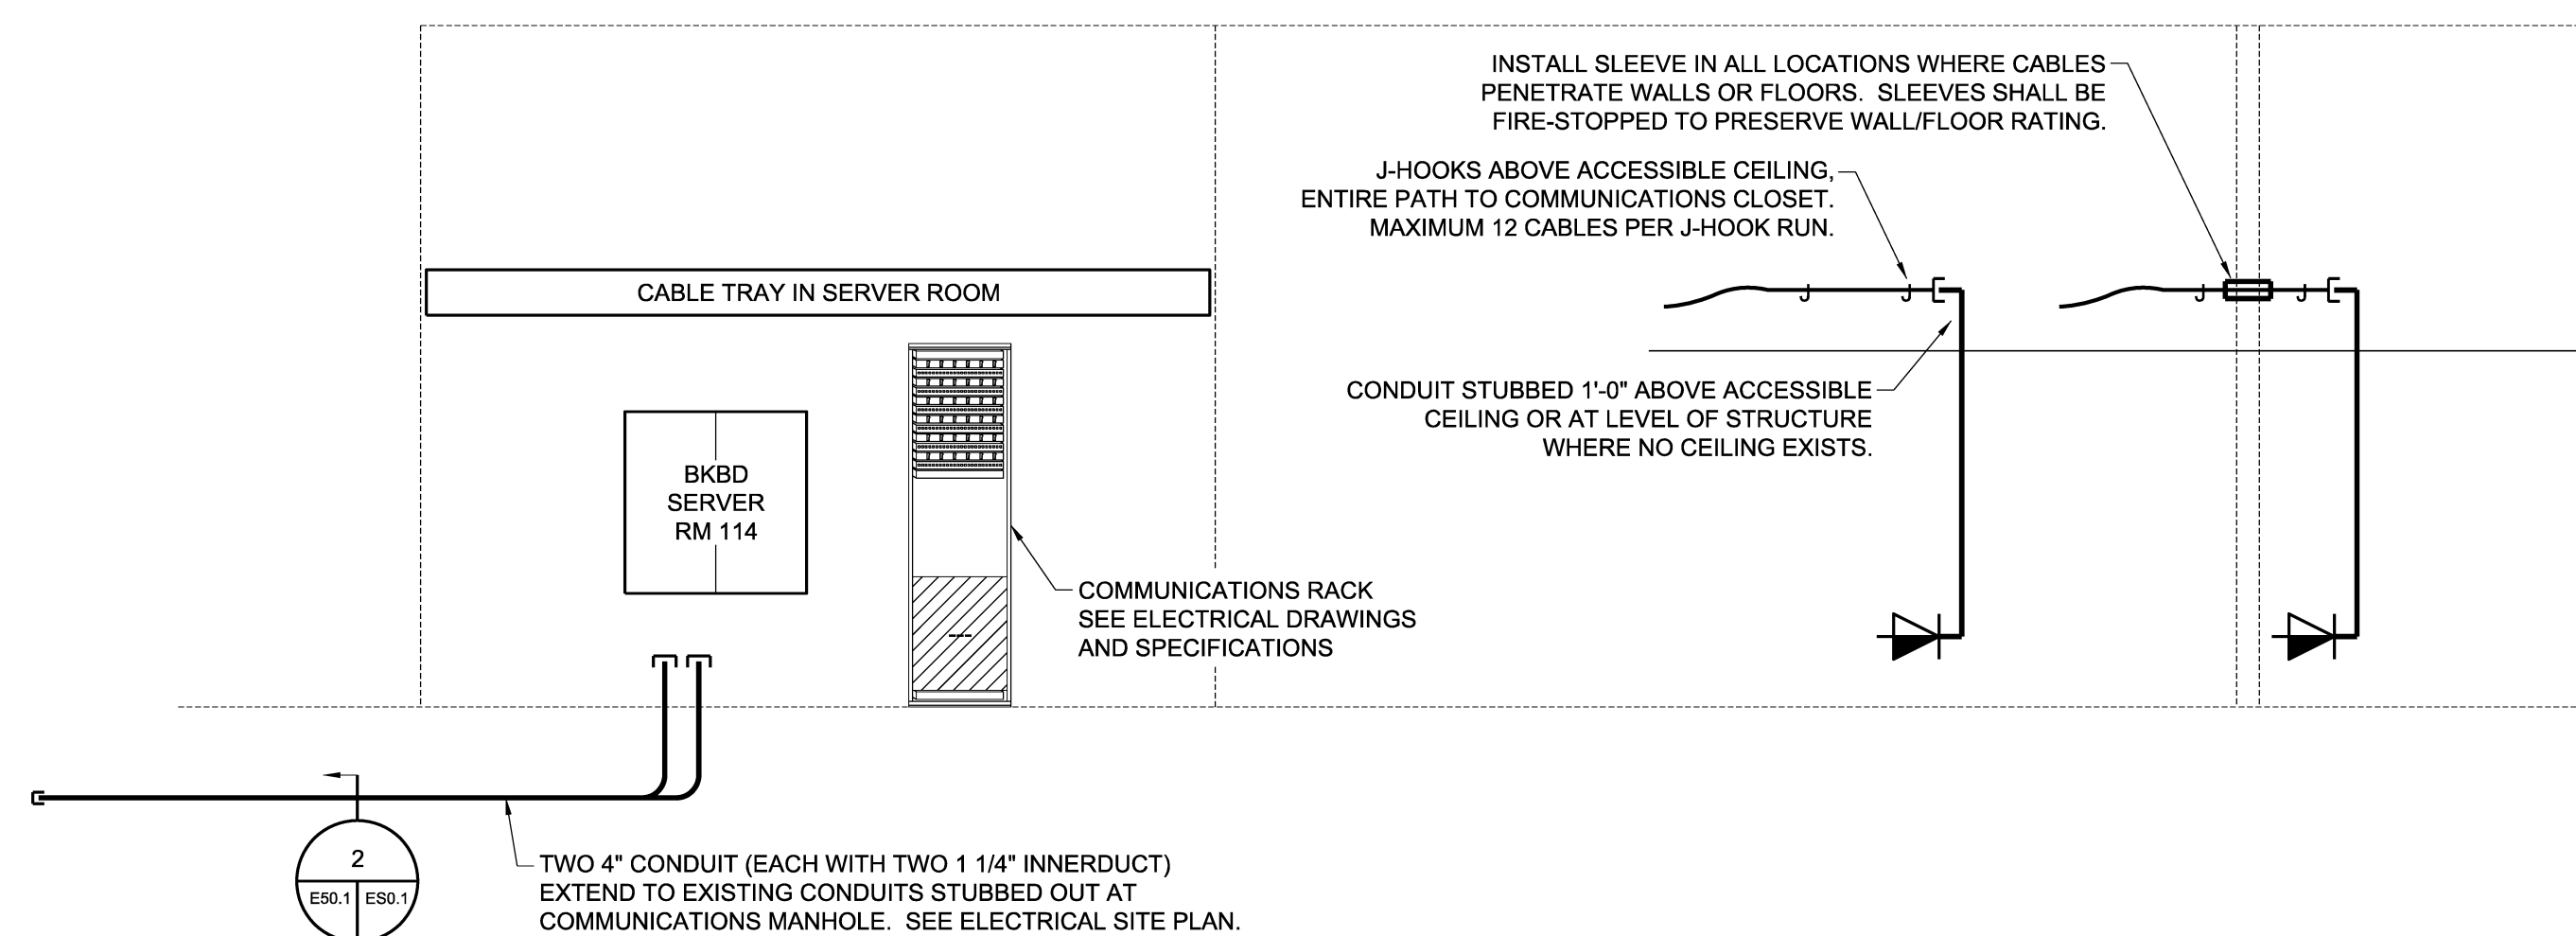

2 COMMUNICATIONS RISER

SCALE: NO SCALE

FEEDER SCHEDULE

(SF380x2) - TWO SETS OF 4#750kcmilAL-4"C EACH PLUS ONE 4"C FROM TRANSFORMER TO MCB

(F50) - 4#6AL&G-1 1/2"C


(F100) - 4#1AL&G-2"C

(F155) - 4#3/0AL&G-2"C

(F205) - 4#250kcmilAL&G-3"C

(F230) - 4#300kcmilAL&G-3"C

(F385) - 4#750kcmilAL&G-4"C

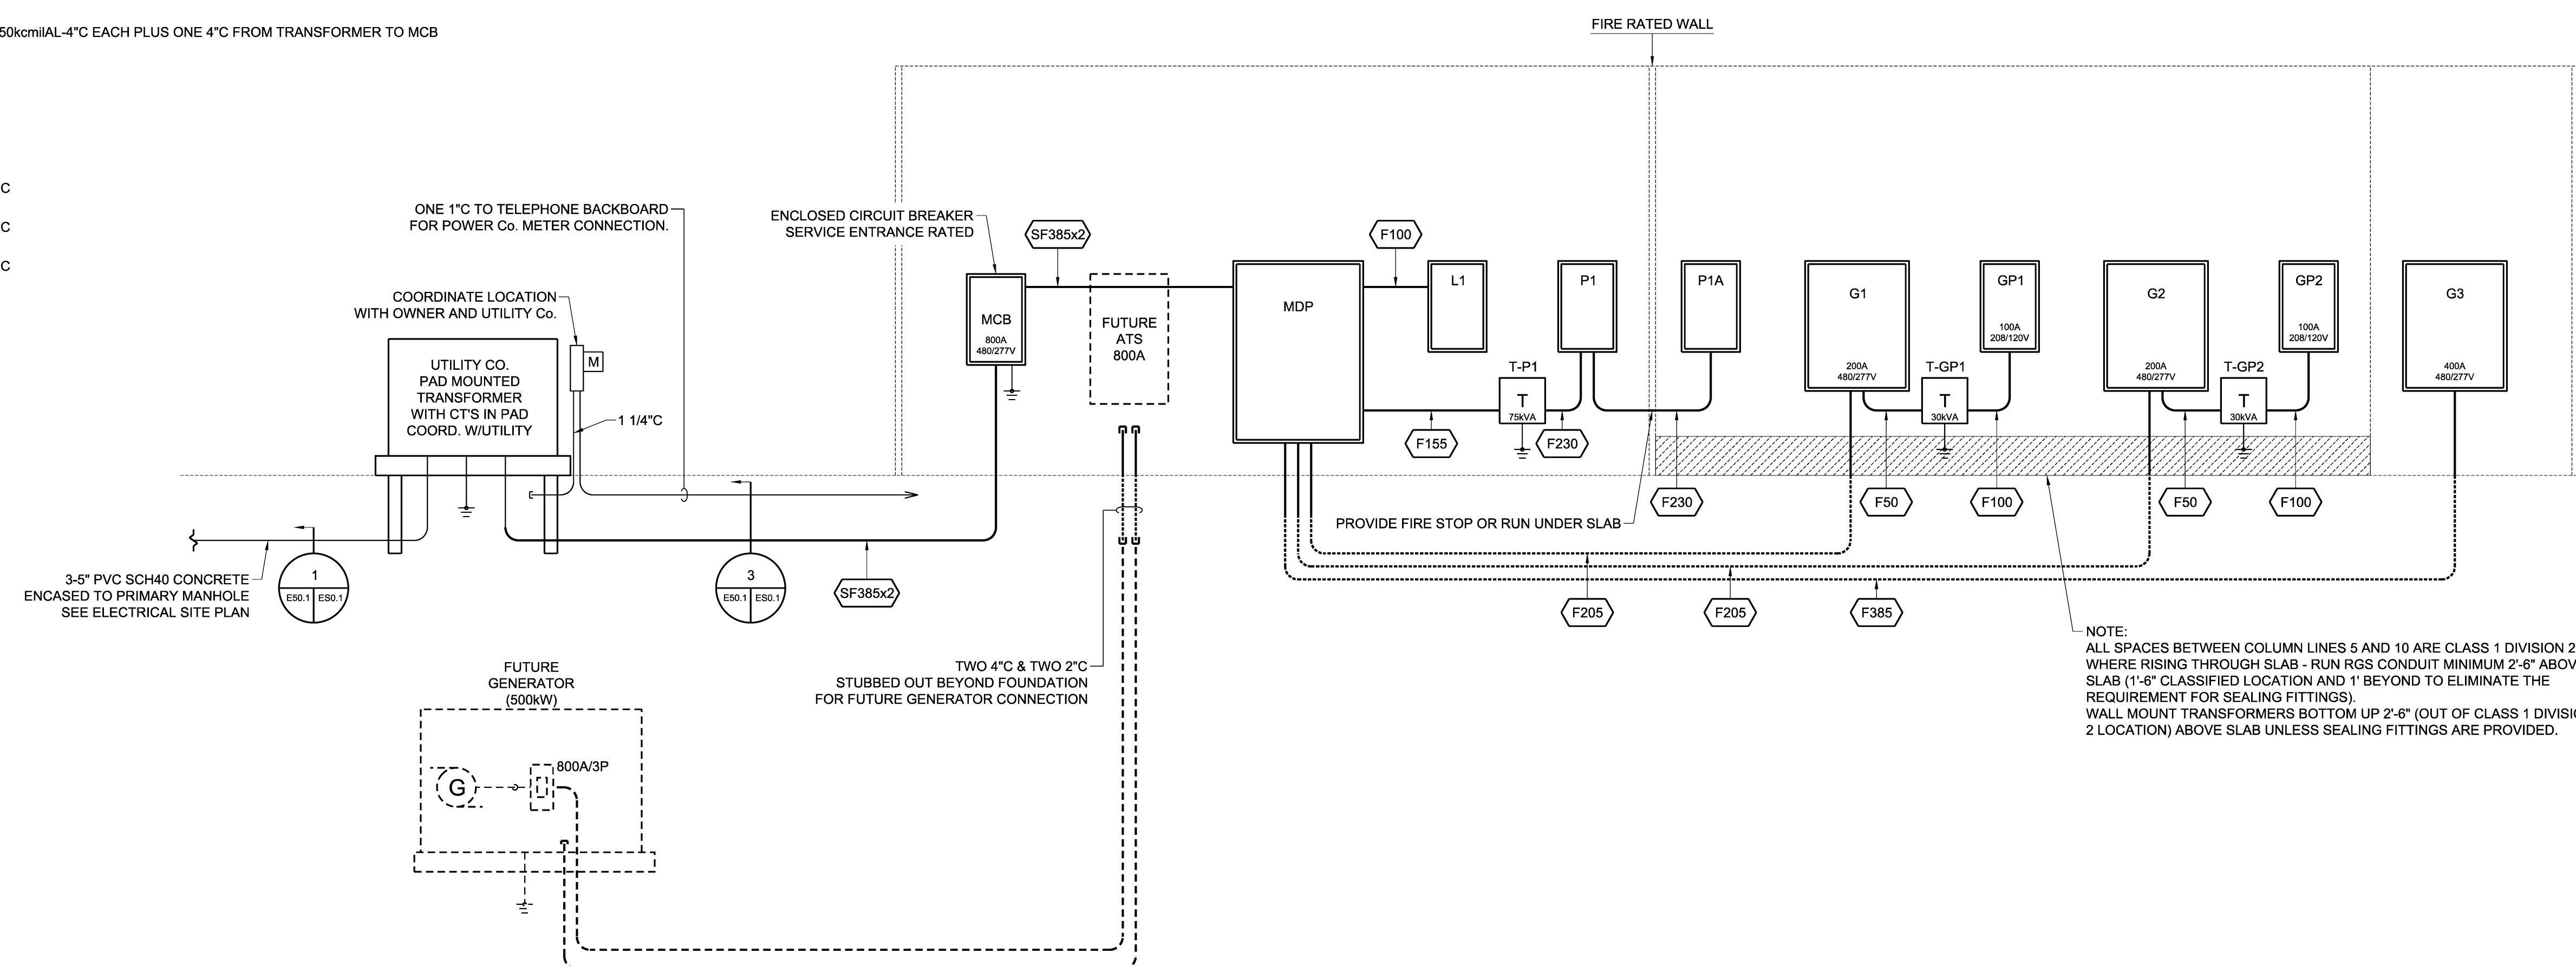


1 POWER RISER

SCALE: NO SCALE

REGIONAL ELECTRIC
LLC
Design Installations Service
207 795-7800

Issues and Revisions

Mark	Date	Description
--	10-20-14	PROGRESS
--	11-14-14	PROGRESS
--	12-08-14	PROGRESS
--	01-14-15	FOR CONSTRUCTION

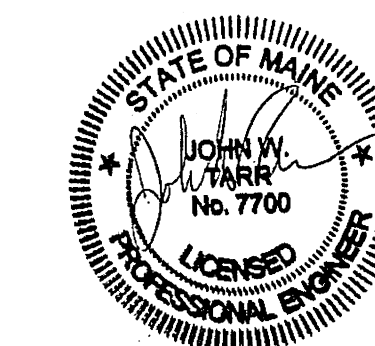

Drawing Scales

PA / PE: JWT

Drawn By: JMB

© 2015
Harriman Associates

RISER
DIAGRAMS

E50.1